


THIS DRAWING IS TO SCALE INDICATED FOR PLANNING PURPOSES ONLY. NO SCALING PERMITTED FOR CONSTRUCTION PURPOSES. ALL DIMENSIONS MUST BE CHECKED ON SITE.

Information on this drawing is copyright, all rights reserved. No part of this work may be reproduced or transmitted in any form by any means, either electronically, mechanically, by photocopying, recording or otherwise stored in any retrieval system of any nature, without the express consent of Philip S Ryley & Co.

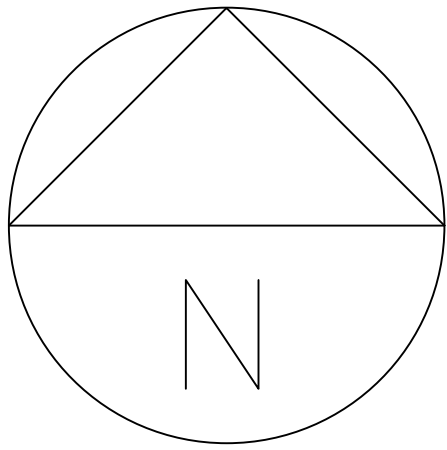


Green – inspection covers

Red – drainage grills

all pipework is 150mmø

Pipe Runs

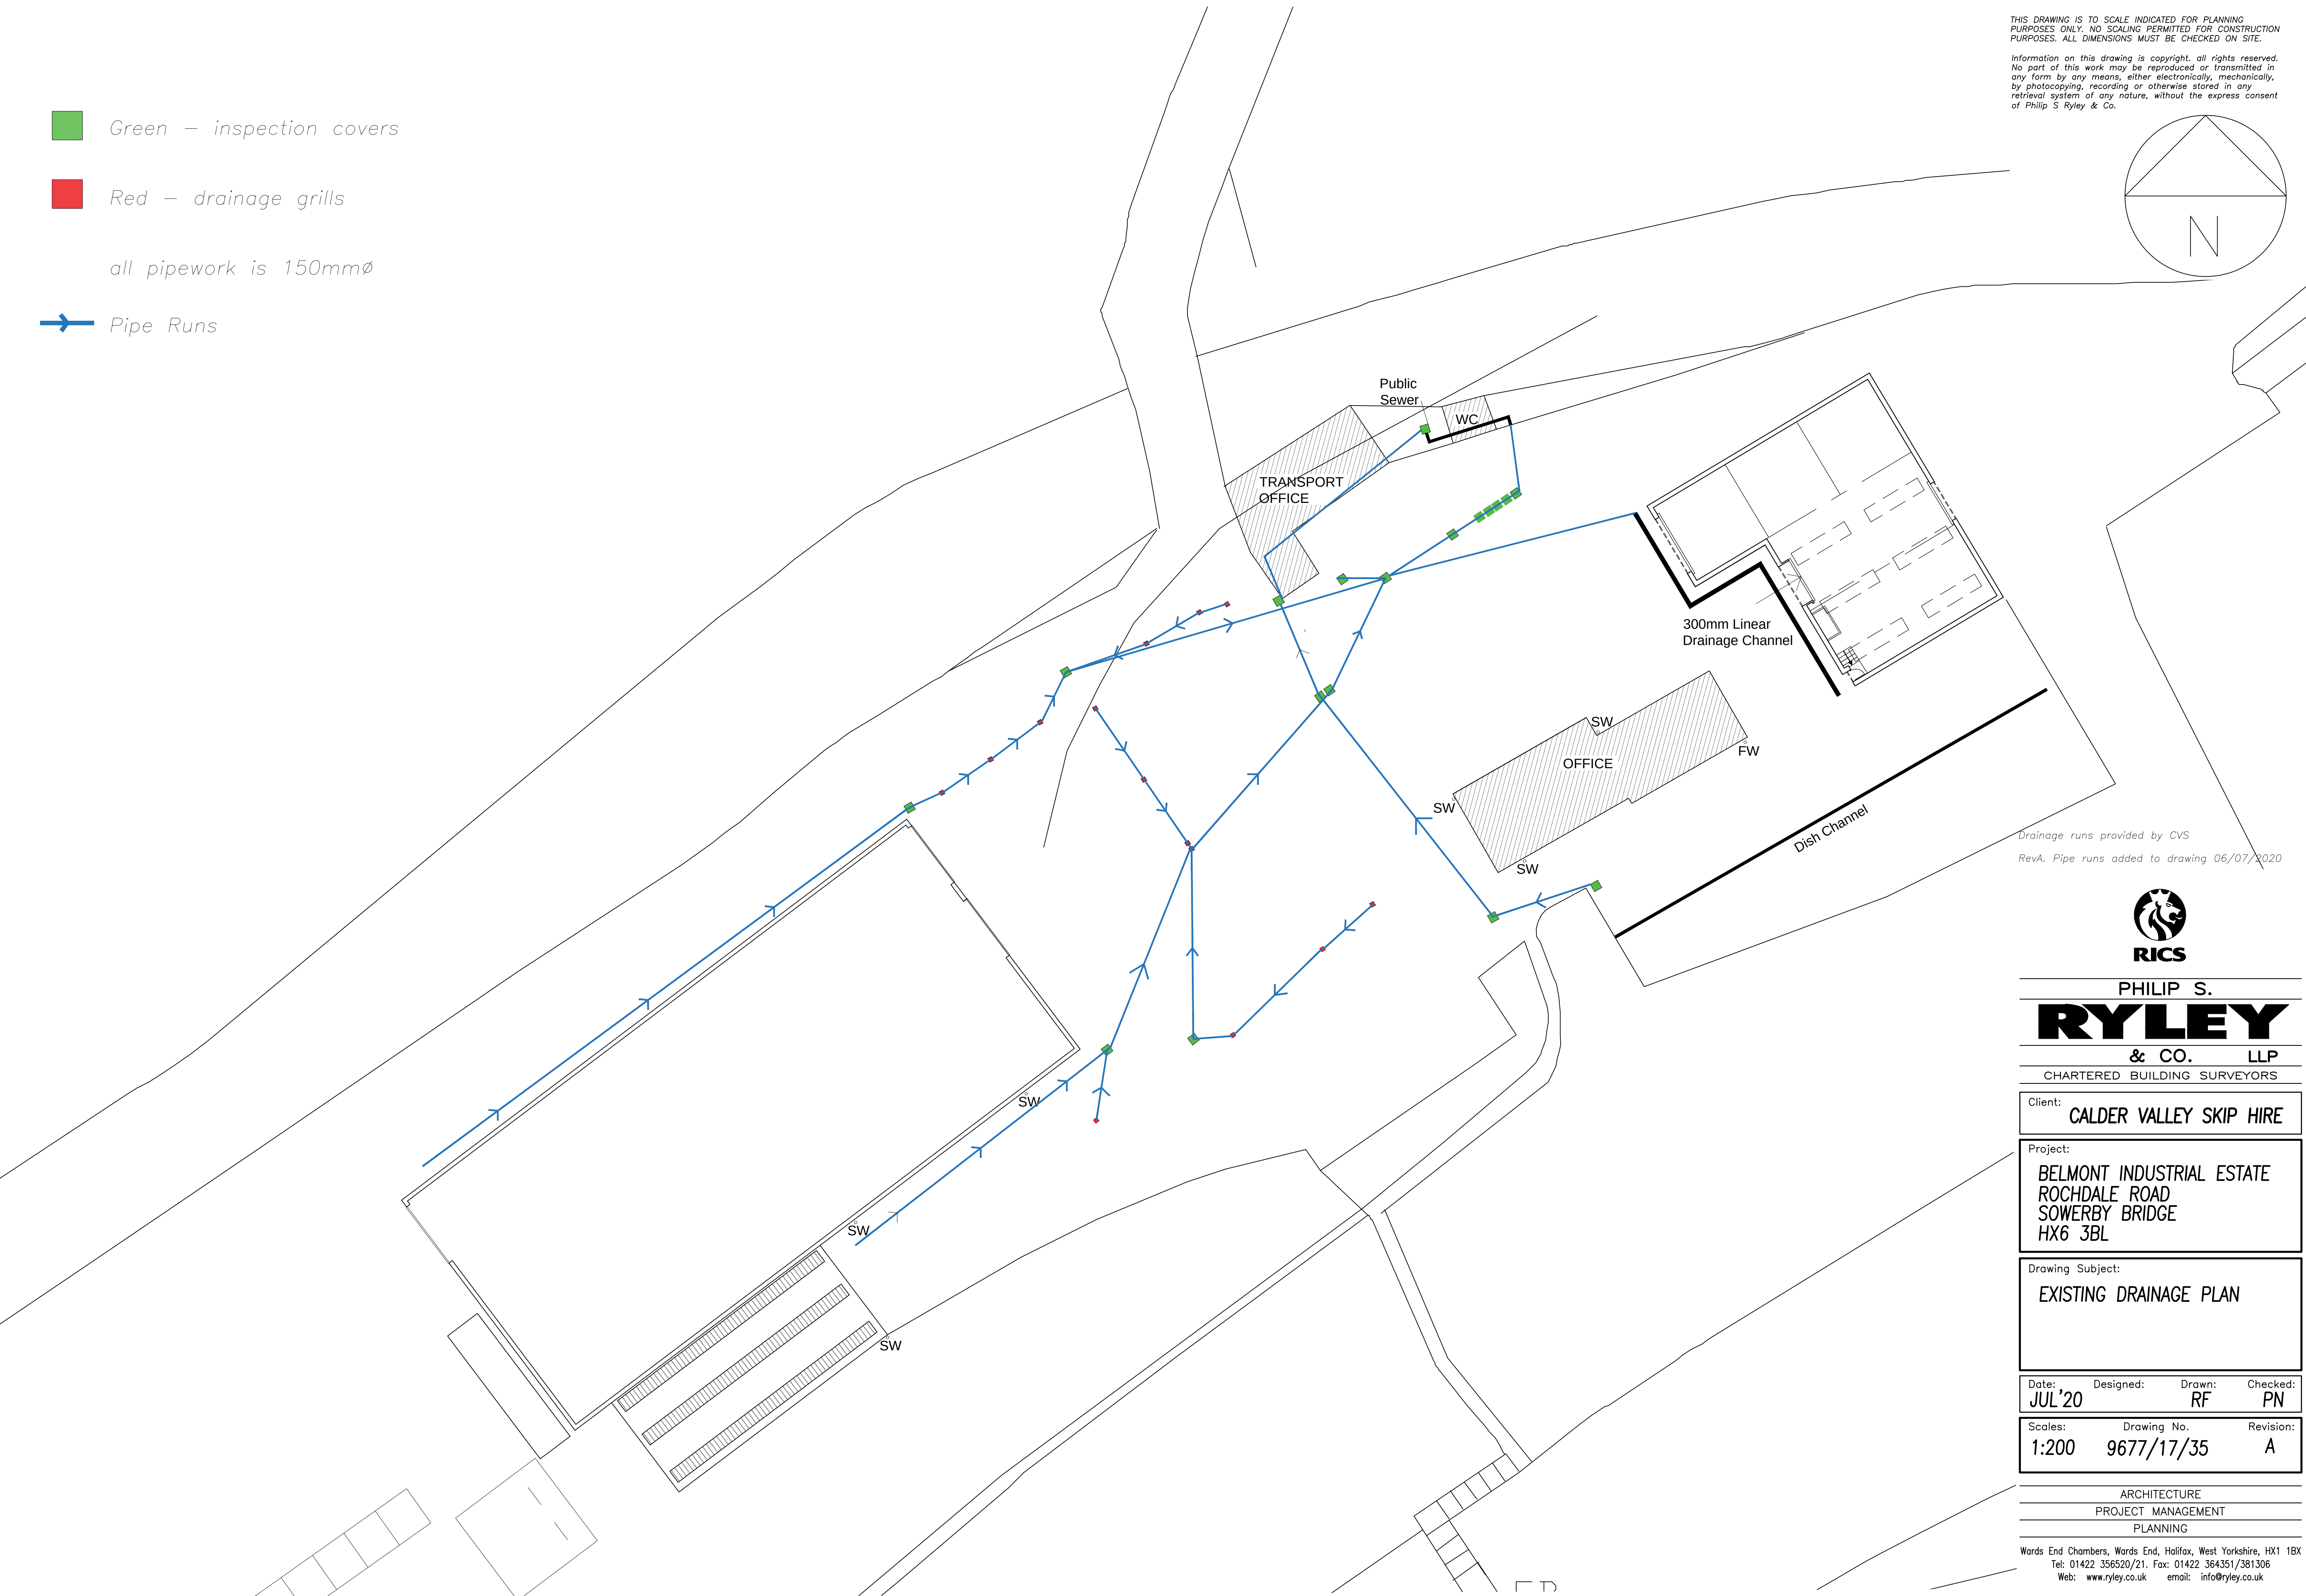

Drainage runs provided by CVS
RevA. Pipe runs added to drawing 06/07/2020



PHILIP S.
RYLEY
& CO. LLP
CHARTERED BUILDING SURVEYORS

Client: **CALDER VALLEY SKIP HIRE**

Project:
**BELMONT INDUSTRIAL ESTATE
ROCHDALE ROAD
SOWERBY BRIDGE
HX6 3BL**

Drawing Subject:
EXISTING DRAINAGE PLAN

Date:	Designed:	Drawn:	Checked:
JUL'20		RF	PN

Scales:	Drawing No.	Revision:
1:200	9677/17/35	A

ARCHITECTURE
PROJECT MANAGEMENT
PLANNING

Wards End Chambers, Wards End, Halifax, West Yorkshire, HX1 1BX
Tel: 01422 356520/21. Fax: 01422 364351/381306
Web: www.ryley.co.uk email: info@ryley.co.uk